

WINDOW SCHEDULE

| SYM. | TYPE | FRAME | WIDTH | HT. | GLAZING | REMARKS |
|------|------|--------|--------|--------|---------|-------------------------|
| A | SF | ALSF-1 | 18'-0" | 9'-0" | G-2 | FIXED GLAZING |
| B | VW | AW-1 | 4'-6" | 5'-0" | G-1 | FIXED, OPERABLE GLAZING |
| C | VW | AW-2 | 6'-0" | 5'-0" | G-1 | FIXED, OPERABLE GLAZING |
| D | VW | AW-3 | 6'-0" | 3'-10" | G-1 | FIXED, OPERABLE GLAZING |
| E | SF | ALSF-2 | 9'-0" | 7'-2" | G-2 | FIXED GLAZING |
| F | VW | AW-4 | 7'-0" | 7'-4" | G-1 | FIXED, OPERABLE GLAZING |
| G | SF | ALSF-3 | 2'-8" | 6'-10" | G-2 | FIXED GLAZING |
| H | SF | ALSF-4 | 1'-8" | 6'-10" | G-2 | FIXED GLAZING |
| J | VW | AW-4 | 5'-0" | 2'-0" | G-1 | OPERABLE GLAZING |
| K | PA | PA-1 | 1'-8" | 6'-10" | G-1 | FIXED GLAZING |
| L | VW | AW-5 | 7'-0" | 3'-0" | G-2 | FIXED CLERESTORY |

FRAME LEGEND



HM HOLLOW STEEL
 PA PREFINISHED ALUMINUM
 SF ALUMINUM STOREFRONT
 VW VINYL WINDOW

GLAZING LEGEND


G-1 1" INSULATING GLASS, HIGH PERFORMANCE, REGULAR STRENGTH
 G-2 1" INSULATING GLASS, HIGH PERFORMANCE, TEMPERED

NOTE: GLAZING WITHIN 24" OF DOORS SHALL BE TEMPERED.

WINDOW TYPES

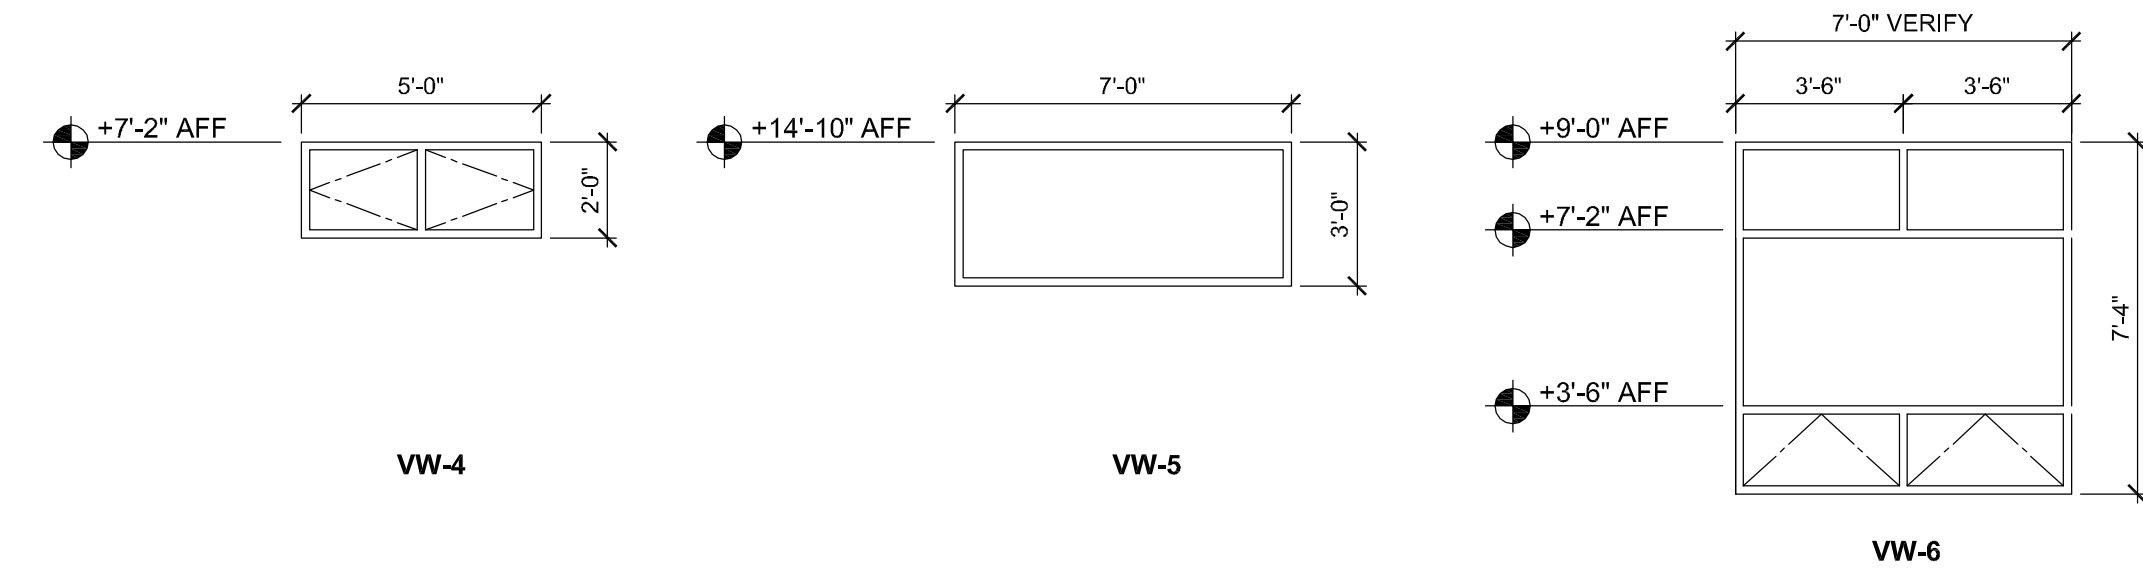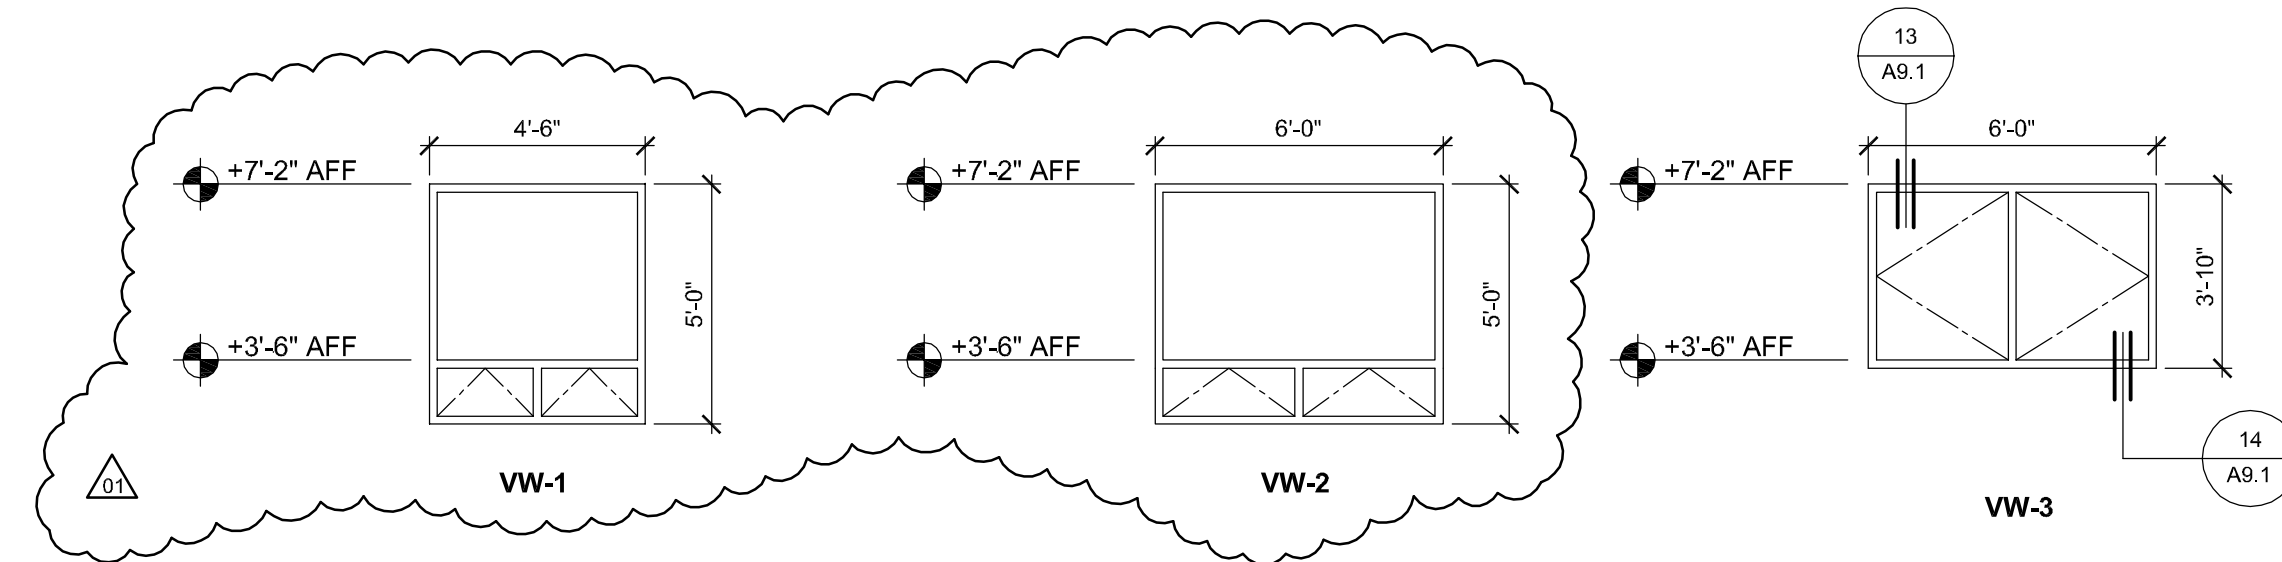

STOREFRONT TYPES

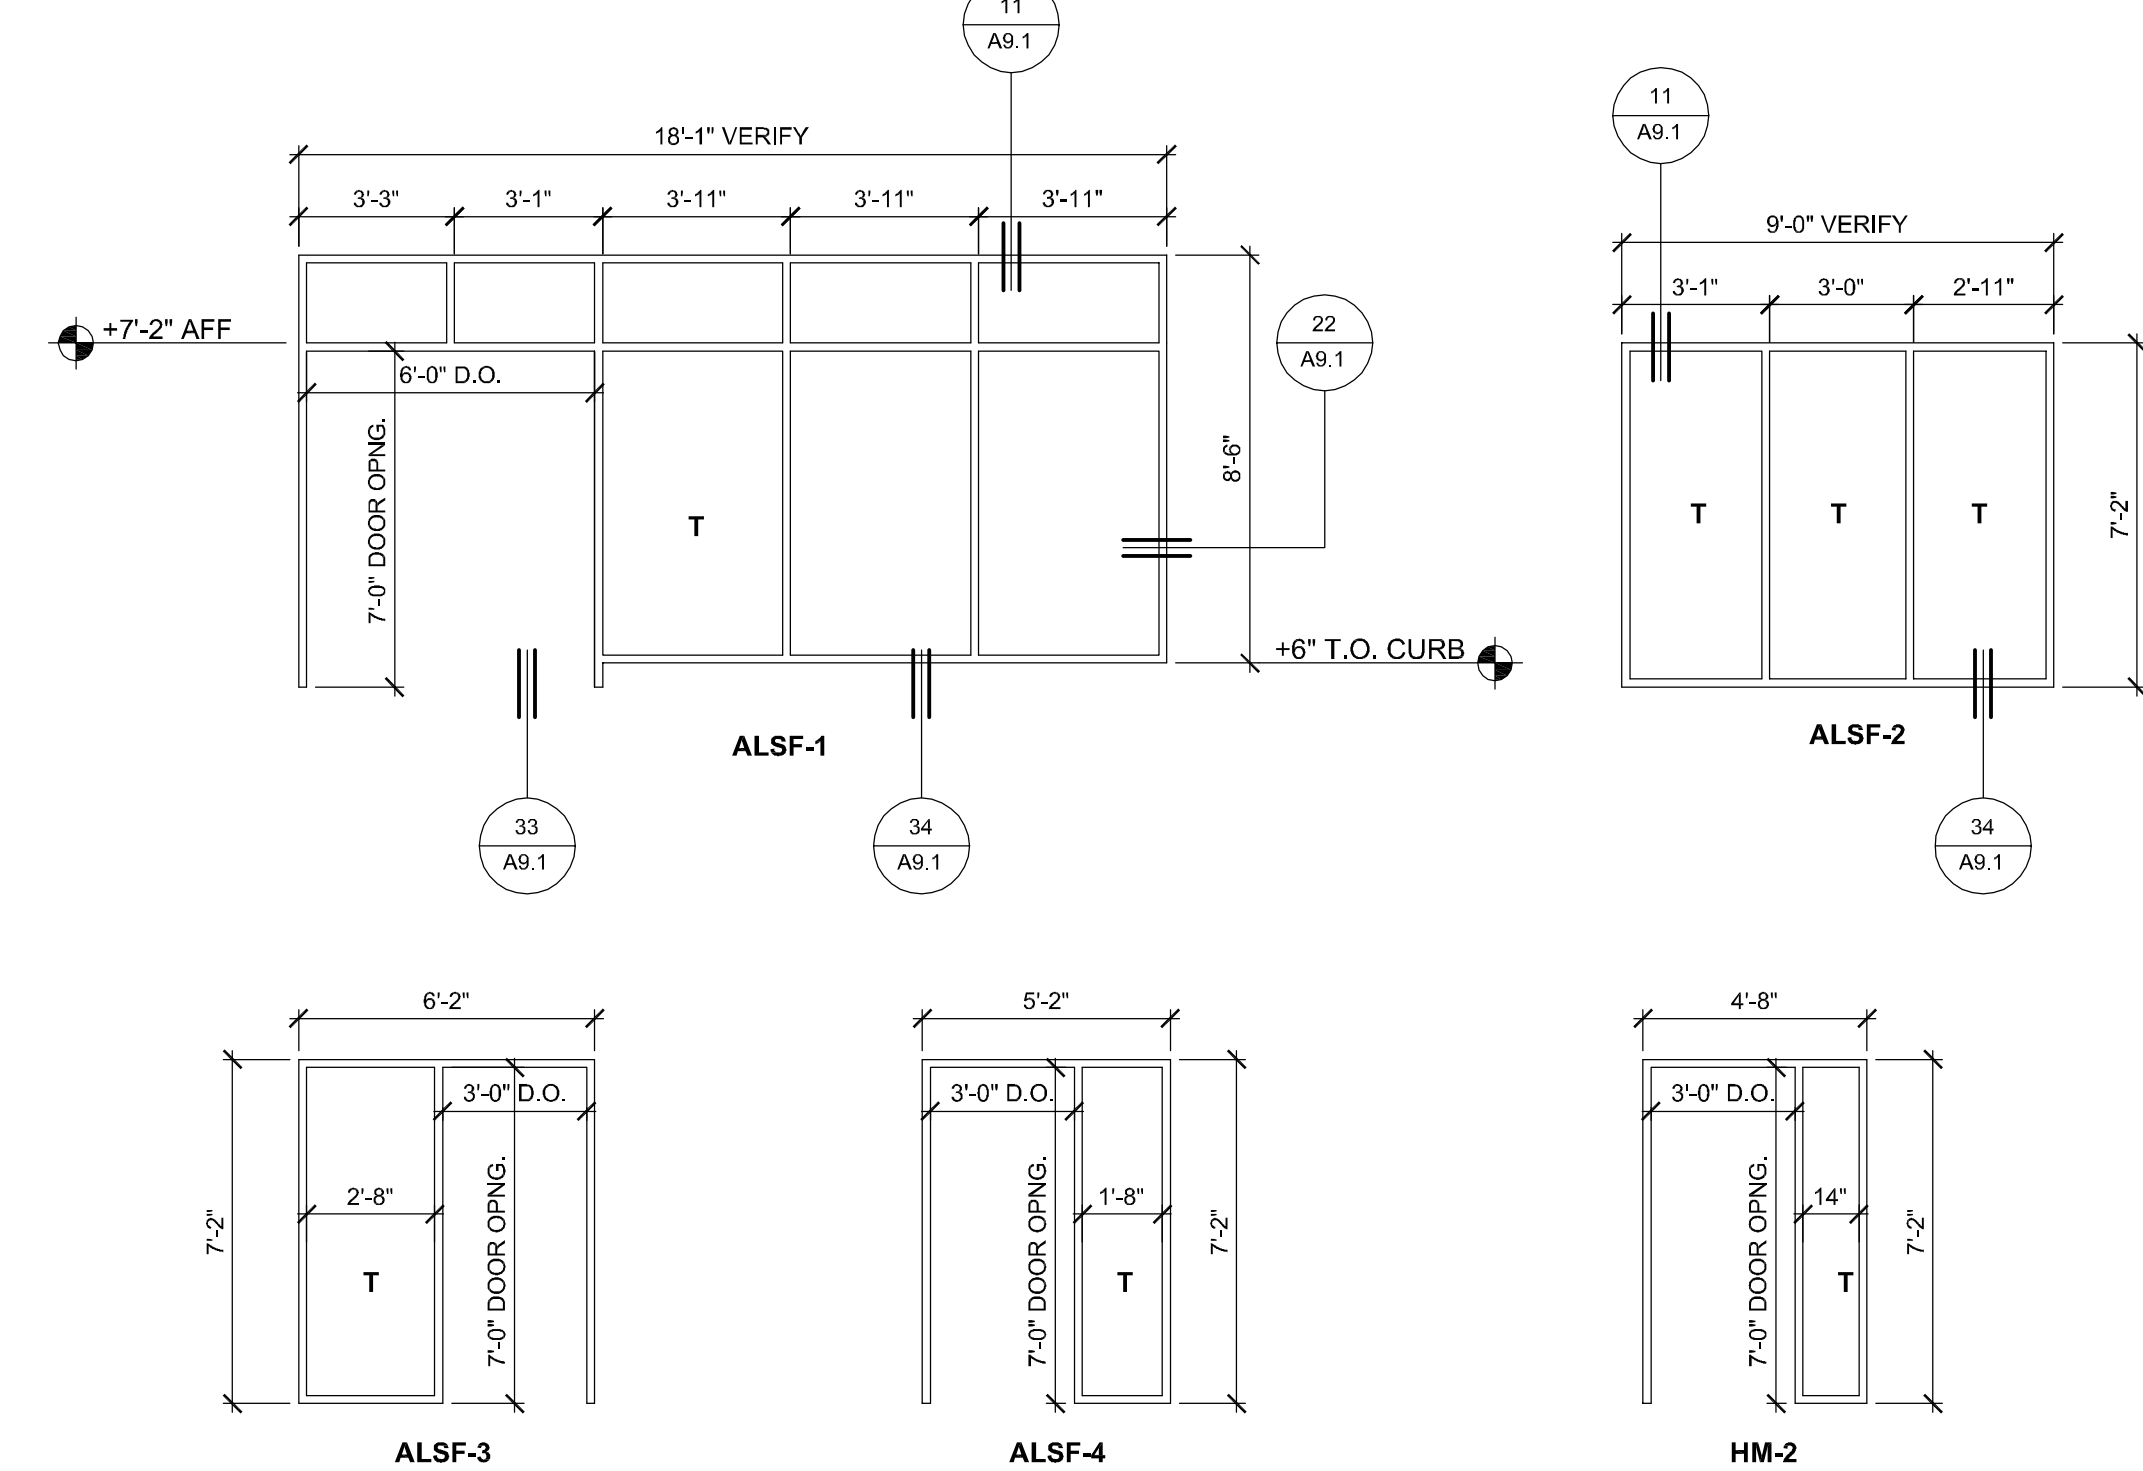

PLAQUE SIGN SCHEDULE

| SIGN | LOCATION | COPY | NOTES (SIGN SIZE W x H) |
|------|--------------------------------|---|---|
| S-1 | SURFACE OF WINDOW | (INTERNATIONAL ACCESSIBILITY SYMBOL) | 9" X 9", ALIGN EXACTLY WITH SIGN ON OPPOSITE SIDE |
| S-2 | SURFACE OF WINDOW | EXIT (+ ACCESSIBILITY SYMBOL) | 9" X 9", ALIGN EXACTLY WITH SIGN ON OPPOSITE SIDE |
| S-3 | WALL MOUNT HINGE SIDE OF DOOR | EXIT (+ ACCESSIBILITY SYMBOL) | 9" X 12" TACTILE "EXIT" 4'-6" FROM EDGE OF DOOR |
| S-4 | WALL MOUNT STRIKE SIDE OF DOOR | (MALE ACCESSIBILITY SYMBOLS) MEN | 6" X 9" MOUNT 4'-6" FROM EDGE OF DOOR |
| S-5 | SURFACE OF DOOR | (MALE SYMBOL) | 12" TRIANGLE |
| S-6 | WALL MOUNT STRIKE SIDE OF DOOR | (FEMALE ACCESSIBILITY SYMBOLS) WOMEN | 6" X 9" MOUNT 4'-6" FROM EDGE OF DOOR |
| S-7 | SURFACE OF DOOR | (FEMALE SYMBOL) | 12" TRIANGLE |
| S-8 | SURFACE OF DOOR | ELECTRICAL TELECOM EQUIPMENT | 9" X 9" |
| S-9 | SURFACE OF DOOR | FIRE SPRINKLER RISER | 9" X 9" |
| S-10 | WALL | OFFICE | 9" X 9" |
| S-11 | WALL | MANAGER | 9" X 9" |
| S-12 | WALL | CLASSROOM | 9" X 9" |
| S-13 | WALL MOUNT ABOVE DOOR | MAXIMUM OCCUPANCY NOT TO EXCEED 74 PERSONS | 9" X 12" |
| S-14 | WALL | LAUNDRY ROOM | 9" X 9" |
| S-15 | SURFACE OF WINDOW | THIS DOOR TO REMAIN UNLOCKED WHEN BUILDING IS OCCUPIED. | 9" X 12" ALIGNED WITH AND ABOVE EXIT SIGN |


DOOR SCHEDULE

| DOOR | TYPE | FRAME | WIDTH | HEIGHT | THICK. | HARDWARE | REMARKS/SIGNAGE |
|------|------|--------|-------|--------|--------|----------|--------------------------------------|
| 1 | AL-2 | ALSF-1 | 6'-0" | 7'-0" | | 1 GLAZED | STOREFRONT ENTRY PAIR |
| 2 | AL-1 | ALSF-5 | 3'-0" | 7'-0" | | 2 GLAZED | STOREFRONT ENTRY |
| 3 | AL-1 | ALSF-4 | 3'-0" | 7'-0" | | 2 GLAZED | STOREFRONT ENTRY |
| 4 | SD-1 | HM-1 | 3'-0" | 7'-0" | 1-3/4" | 3 FLUSH | FLUSH PANEL SIGN: ELECTRICAL ROOM |
| 5 | SD-2 | HM-1 | 3'-0" | 7'-0" | 1-3/4" | 4 GLAZED | PAINT GRADE |
| 6 | SD-2 | HM-1 | 3'-0" | 7'-0" | 1-3/4" | 4 GLAZED | PAINT GRADE |
| 7 | WD-1 | HM-2 | 3'-0" | 6'-8" | 1-3/4" | 5 GLAZED | SIGN: CLASSROOM |
| 8 | WD-2 | HM-1 | 3'-0" | 6'-8" | 1-3/4" | 5 | STAIN GRADE |
| 9 | WD-4 | HM-1 | 6'-0" | 6'-8" | 1-3/4" | 6 GLAZED | STAIN GRADE |
| 10 | WD-2 | HM-1 | 3'-0" | 6'-8" | 1-3/4" | 7 FLUSH | STAIN GRADE, ACCESSIBLE BATH SIGNAGE |
| 11 | WD-2 | HM-1 | 3'-0" | 6'-8" | 1-3/4" | 7 FLUSH | STAIN GRADE, ACCESSIBLE BATH SIGNAGE |
| 12 | WD-3 | HM-1 | 3'-0" | 6'-8" | 1-3/4" | 8 FLUSH | STAIN GRADE, SIGN: FIRE RISER ROOM |
| 13 | WD-2 | HM-1 | 3'-0" | 6'-8" | 1-3/4" | 5 GLAZED | STAIN GRADE |
| 14 | WD-5 | HM-1 | 3'-0" | 6'-8" | 1-3/4" | 5 GLAZED | STAIN GRADE |
| 15 | WD-2 | HM-1 | 3'-0" | 6'-8" | 1-3/4" | 9 | STAIN GRADE |
| 16 | WD-4 | HM-1 | 6'-0" | 6'-8" | 1-3/4" | 10 FLUSH | STAIN GRADE |
| 17 | WD-6 | HM-1 | 6'-0" | 6'-8" | 1-3/4" | 10 FLUSH | STAIN GRADE |

DOOR HARDWARE SCHEDULE

- GROUP 1**
 Hinges: 6 pivots, heavy duty
 Lock: keyed cylinder
 Pulls: 2, offset single acting
 Push Bar: 2, full width
 Closers: 2, concealed head mounted
 Threshold: accessible saddle, full width
 Door Bottoms: nylon brush sweep
 Seals: adhered vinyl, jamb and head
- GROUP 2**
 Hinges: 3 pivots, heavy duty
 Lock: keyed cylinder
 Pulls: 1, offset single acting
 Push Bar: 1, full width
 Closers: 2, concealed head mounted, hold open
 Threshold: accessible saddle, full width
 Door Bottom: vinyl brush sweep
 Seals: adhered vinyl, jamb and head
- GROUP 3**
 Hinges: 3, standard duty brass or stainless steel
 Lockset: heavy duty storeroom function, lever handle
 Threshold: accessible saddle, full width
 Door Bottom: full shoe, vinyl sweep
 Seals: silicone bulb, head and jambs
- GROUP 4**
 Hinges: 3, heavy duty brass or stainless steel
 Lockset: heavy duty entry/office function, lever handle
 Threshold: accessible saddle, full width
 Door Bottom: full shoe, vinyl sweep
 Seals: silicone bulb, head and jambs
- GROUP 5**
 Hinges: 3, standard duty
 Lockset: standard duty entry/office function, lever handle
 Stop: heavy duty wall base stop
 Seals: adhered vinyl, head and jamb
- GROUP 6**
 Hinges: 6, ball bearing
 Active Leaf Lockset: heavy duty entry/office function, lever handle
 Inactive Leaf Bolt: heavy duty flush bolts, top and bottom
 Closer: 2, inside surface mount, hold-open
 Stops: heavy duty wall stop
 Seals: adhered vinyl, head and jamb
- GROUP 7**
 Hinges: 3, heavy duty
 Closer: inside surface mount
 Push Plate: 4" x 16"
 Pull: 8", on 4" x 16" plate
 Mop Plate: 8" x door width, inside
 Stop: heavy duty wall stop
 Push Plate, Pull
 Seals: adhered vinyl, jamb and head
- GROUP 8**
 Hinges: 3, standard duty
 Lockset: standard duty storeroom function, lever handle
 Stop: heavy duty wall base stop
 Seals: adhered vinyl, head and jamb
- GROUP 9**
 Hinges: 3, standard duty
 Lockset: standard duty storeroom function, lever handle
 Stop: heavy duty wall base stop
- GROUP 10**
 Hinges: 6, standard duty
 Active Leaf Latchset: heavy duty passage
 Inactive Leaf Bolts: heavy duty flush bolts, top and bottom

DOOR TYPES

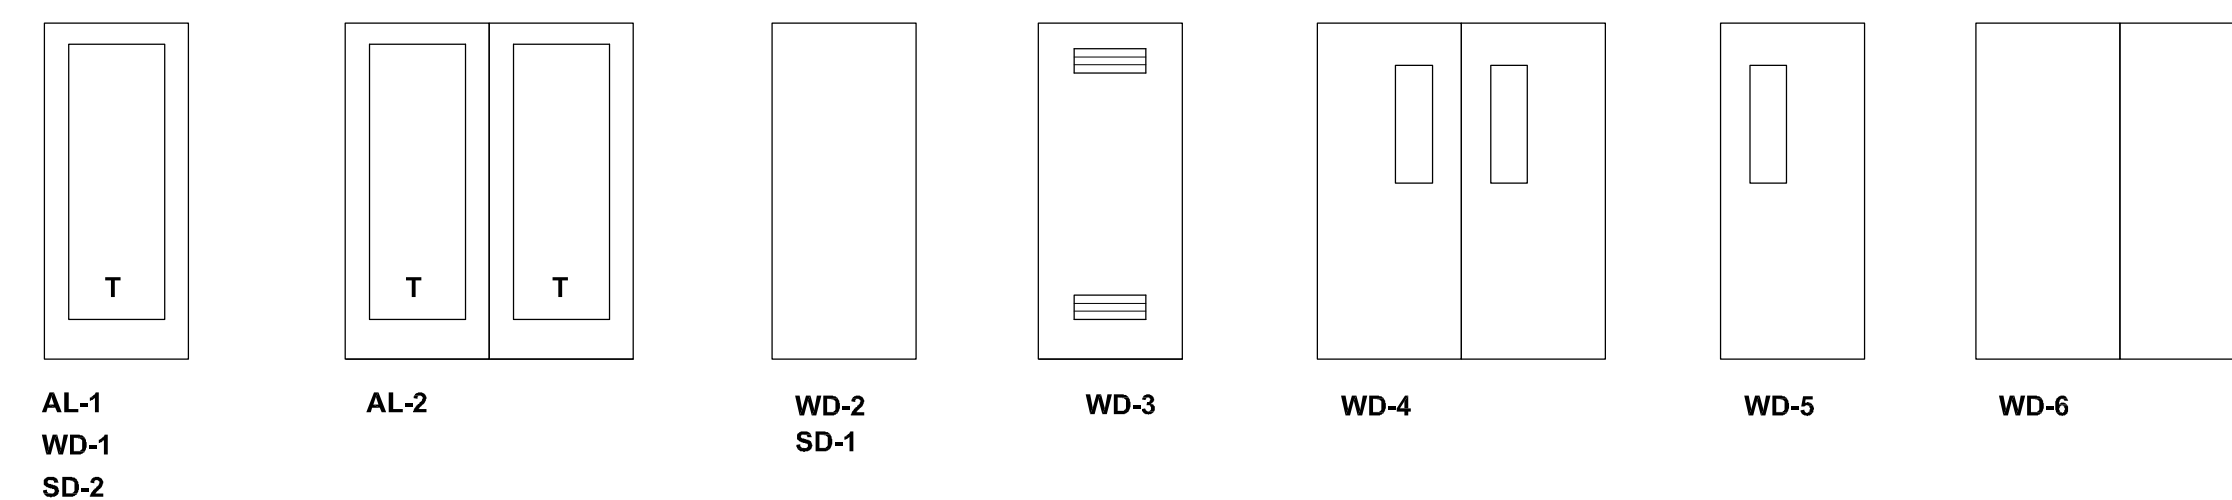

FINISH SCHEDULES

| ROOM NAME | FLOOR | BASE | WALLS/CEILING | CEILING |
|---------------------|-------|------|---------------|---------|
| WAITING | RF-1 | RB-1 | GB-1 | GB-1 |
| CLASSROOM | CAR-1 | RB-1 | GB-1 | AC-1 |
| OFFICE | CAR-1 | RB-1 | GB-1 | AC-1 |
| FILE OFFICE STORAGE | RF-2 | RB-1 | GB-1 | GB-1 |
| COUNSELING OFFICE | CAR-1 | RB-1 | GB-1 | AC-1 |
| ELECTRICAL | SC-1 | NONE | GB-2 | GB-2 |
| MECHANICAL | SC-1 | NONE | GB-2 | GB-2 |
| MEN'S RESTROOM | CT-1 | CT-2 | CT-3 | GB-1 |
| WOMEN'S RESTROOM | CT-1 | CT-2 | CT-3 | GB-1 |
| KITCHEN | RF-1 | RB-1 | GB-1 | GB-1 |
| MULTI-PURPOSE | RF-1 | RB-1 | GB-1 | AC-2 |
| STORAGE | RF-2 | RB-1 | GB-1 | GB-1 |
| LAUNDRY | RF-2 | RB-1 | GB-1 | GB-1 |
| HALL | RF-1 | RB-1 | GB-1 | GB-1 |

FINISH LEGEND

| FLOOR | |
|-------|---|
| RF-1 | 12"x12" VINYL COMPOSITION TILE, 3-COLOR PATTERN |
| RF-2 | 12"x12" VINYL COMPOSITION TILE, 1 COLOR |
| CAR-1 | LEVEL LOOP CARPET WITH PAD, 20 OZ |
| CT-1 | 2" X 2" UNGLAZED CERAMIC TILE |
| SC-1 | SEALED CONCRETE |

| BASE | |
|------|---------------------------------|
| RB-1 | 4" STRAIGHT RESILIENT WALL BASE |
| CT-2 | COVED CERAMIC TILE BASE |

| WALLS | |
|-------|--|
| GB-1 | GYPSUM BOARD, TEXTURED, SEMI-GLOSS PAINT |
| GB-2 | GYPSUM BOARD, TAPE ONLY, FLAT PAINT |
| CT-3 | 4-1/4" X 4-1/4" GLAZED CERAMIC TILE |
| FRP-1 | FIBERGLASS REINFORCED PANEL |

| CEILING | |
|---------|--|
| GB-1 | GYPSUM BOARD, TEXTURED, SEMI-GLOSS PAINT |
| GB-2 | GYPSUM BOARD, TAPE ONLY, FLAT PAINT |
| AC-1 | SUSPENDED ACOUSTIC TILE |
| AC-2 | ACOUSTIC PANELS |

GENERAL DOOR NOTES:

- THE UNLATCHING OF ANY EXIT DOOR SHALL NOT REQUIRE MORE THAN ONE OPERATION.
- ALL EXIT DOORS SHALL BE OPENABLE FROM THE INSIDE WITHOUT THE USE OF A KEY OR ANY SPECIAL KNOWLEDGE.
- HC ACCESSIBLE DOOR HARDWARE SHALL BE CENTERED BETWEEN 30 AND 44 INCHES ABOVE FINISH FLOOR OR LANDING, AND SHALL BE OPERATED WITH SINGLE PUSH-PULL ACTIVATING BARS OR OTHER HARDWARE DESIGNED TO PROVIDE PASSAGE WITHOUT REQUIRING THE ABILITY TO GRASP THE OPENING HARDWARE.
- INTERIOR AND EXTERIOR THRESHOLDS SHALL BE NO HIGHER THAN 1/2 INCH ABOVE ADJACENT FLOOR LEVELS. HC ACCESSIBLE THRESHOLDS SHALL BE REQUIRED TO BE SLOPED A MINIMUM OF 2 HORIZONTAL TO 1 VERTICAL SO THAT NO VERTICAL CHANGE OF ELEVATION EXCEEDS 1/4 INCH.
- ON DOORS THAT HAVE CLOSERS, THE DOOR CLOSER PRESSURE SHALL NOT EXCEED 5 POUNDS. EXTERIOR DOORS SHALL OPEN WITH A MAXIMUM EFFORT OF 5 POUNDS OF PRESSURE.
- THE BOTTOM 10 INCHES OF ALL HC ACCESSIBLE DOORS SHALL HAVE A SMOOTH UNINTERRUPTED SURFACE TO ALLOW THE DOOR TO BE OPENED BY A WHEELCHAIR FOOTREST.
- ALL GLAZING IN DOORS SHALL BE TEMPERED.
- REFER TO SPECIFICATION SECTION 10400 FOR DOOR SIGNAGE REQUIREMENTS.
- PROVIDE A 60"x60" CLEAR LEVEL AREA AT WALK ADJACENT TO DOOR/GATE WHEN DOOR/GATE SWINGS TOWARD WALK.
- PROVIDE A 48"x44" CLEAR LEVEL AREA AT WALK ADJACENT TO DOOR/GATE WHEN DOOR/GATE SWINGS AWAY FROM WALK.
- THE FOLLOWING SHALL APPLY TO THE MAIN EXTERIOR DOOR



- THE LOCKING DEVICE SHALL BE REDILY DISTINGUISHABLE AS LOCKED
- A READILY VISIBLE DURABLE SIGN SHALL BE POSTED ON THE EGRESS SIDE ON OR ADJACENT TO THE DOOR STATING: "THIS DOOR IS TO REMAIN UNLOCKED WHEN BUILDING IS OCCUPIED" THE SIGN SHALL BE IN LETTERS 1 INCH HIGH ON A CONTRASTING BACKGROUND.

PROJECT

ROLLING HILLS APARTMENTS

NEW COMMON BUILDING

LAS TABLAS ROAD
 TEMPLETON, CA

CLIENT JOB # ARCHITECT JOB #
 0708B



PROJECT MANAGER BDF


DRAWN BY DDL

DATES DESIGN DEVELOPMENT 4/15/10

FIRST SUBMITTAL 6/02/10

PLAN CHECK 1 8/16/10

SIGNED

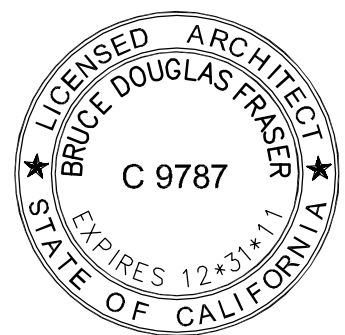

The use of these plans and specifications shall be restricted to the original site for which they were prepared and publication thereof is expressly limited to such use. Reproduction or publication by any method, in whole or in part, is prohibited. Title to these plans and specifications remain with the architect without prejudice. Visual contact with these plans and specifications shall constitute prima facie evidence of the acceptance of these restrictions.

Written dimensions on these drawings shall have precedence over scaled dimensions. Contractors shall verify and be responsible for all dimensions and existing conditions on the job and shall report any discrepancies to the architect for resolution prior to commencing work.

SHEET TITLE

DOOR, WINDOW, STOREFRONT SCHEDULES

SHEET #

A8.1